


A 281.5

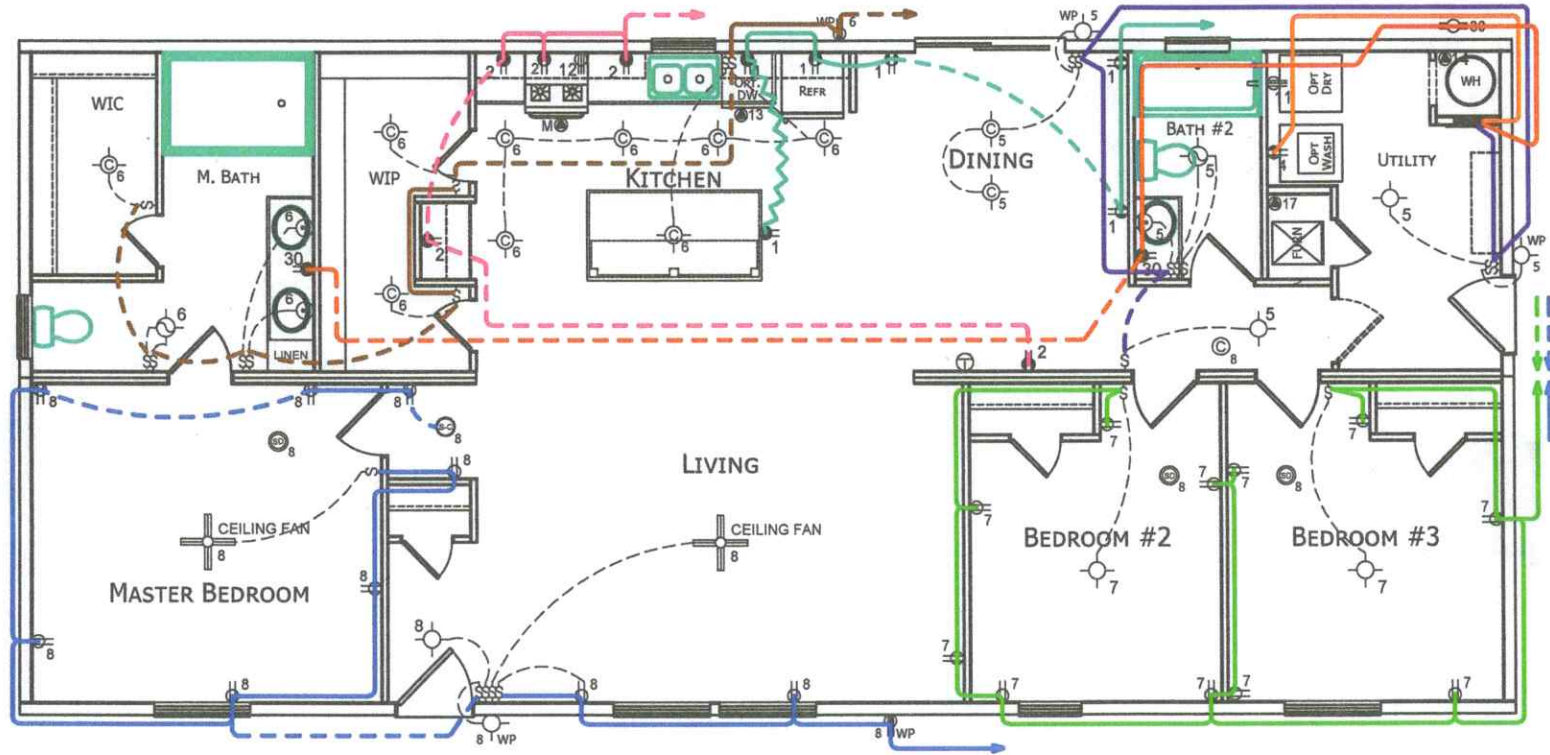

* BATHROOM GFI CIRCUIT TO BE ON GFI BREAKER *

Wire in ceiling ---
 Wire in wall - - -
 Wire in floor ~ ~ ~



308 SHERIDAN DRIVE TOPEKA, IN 46571

APPROVER'S SEAL

MODIFICATIONS

1	ADDED OPT. UTILITY SINK	JR	02-27-17
2	ADDED 3" TO MATEWALL	JR	04-13-17
3	ADDED OPTIONAL UK2 KITCHEN	JR	09-16-20
4	REVISED CO ALARMS	TWC	04-21-22

PROPRIETARY AND CONFIDENTIAL
 THESE DRAWINGS AND SPECIFICATIONS ARE ORIGINAL,
 PROPRIETARY AND CONFIDENTIAL MATERIALS OF CHAMPION.
 COPYRIGHT - 4976-2008 BY CHAMPION

MODEL: 2864 IS3
 3BD 2BATH

TITLE: FLOOR PLAN

DRAWN BY: KG

DATE: 11-20-19

SCALE: 1/8" = 1'-0"

SHEET:

AP-101